


FURNITURE PLAN

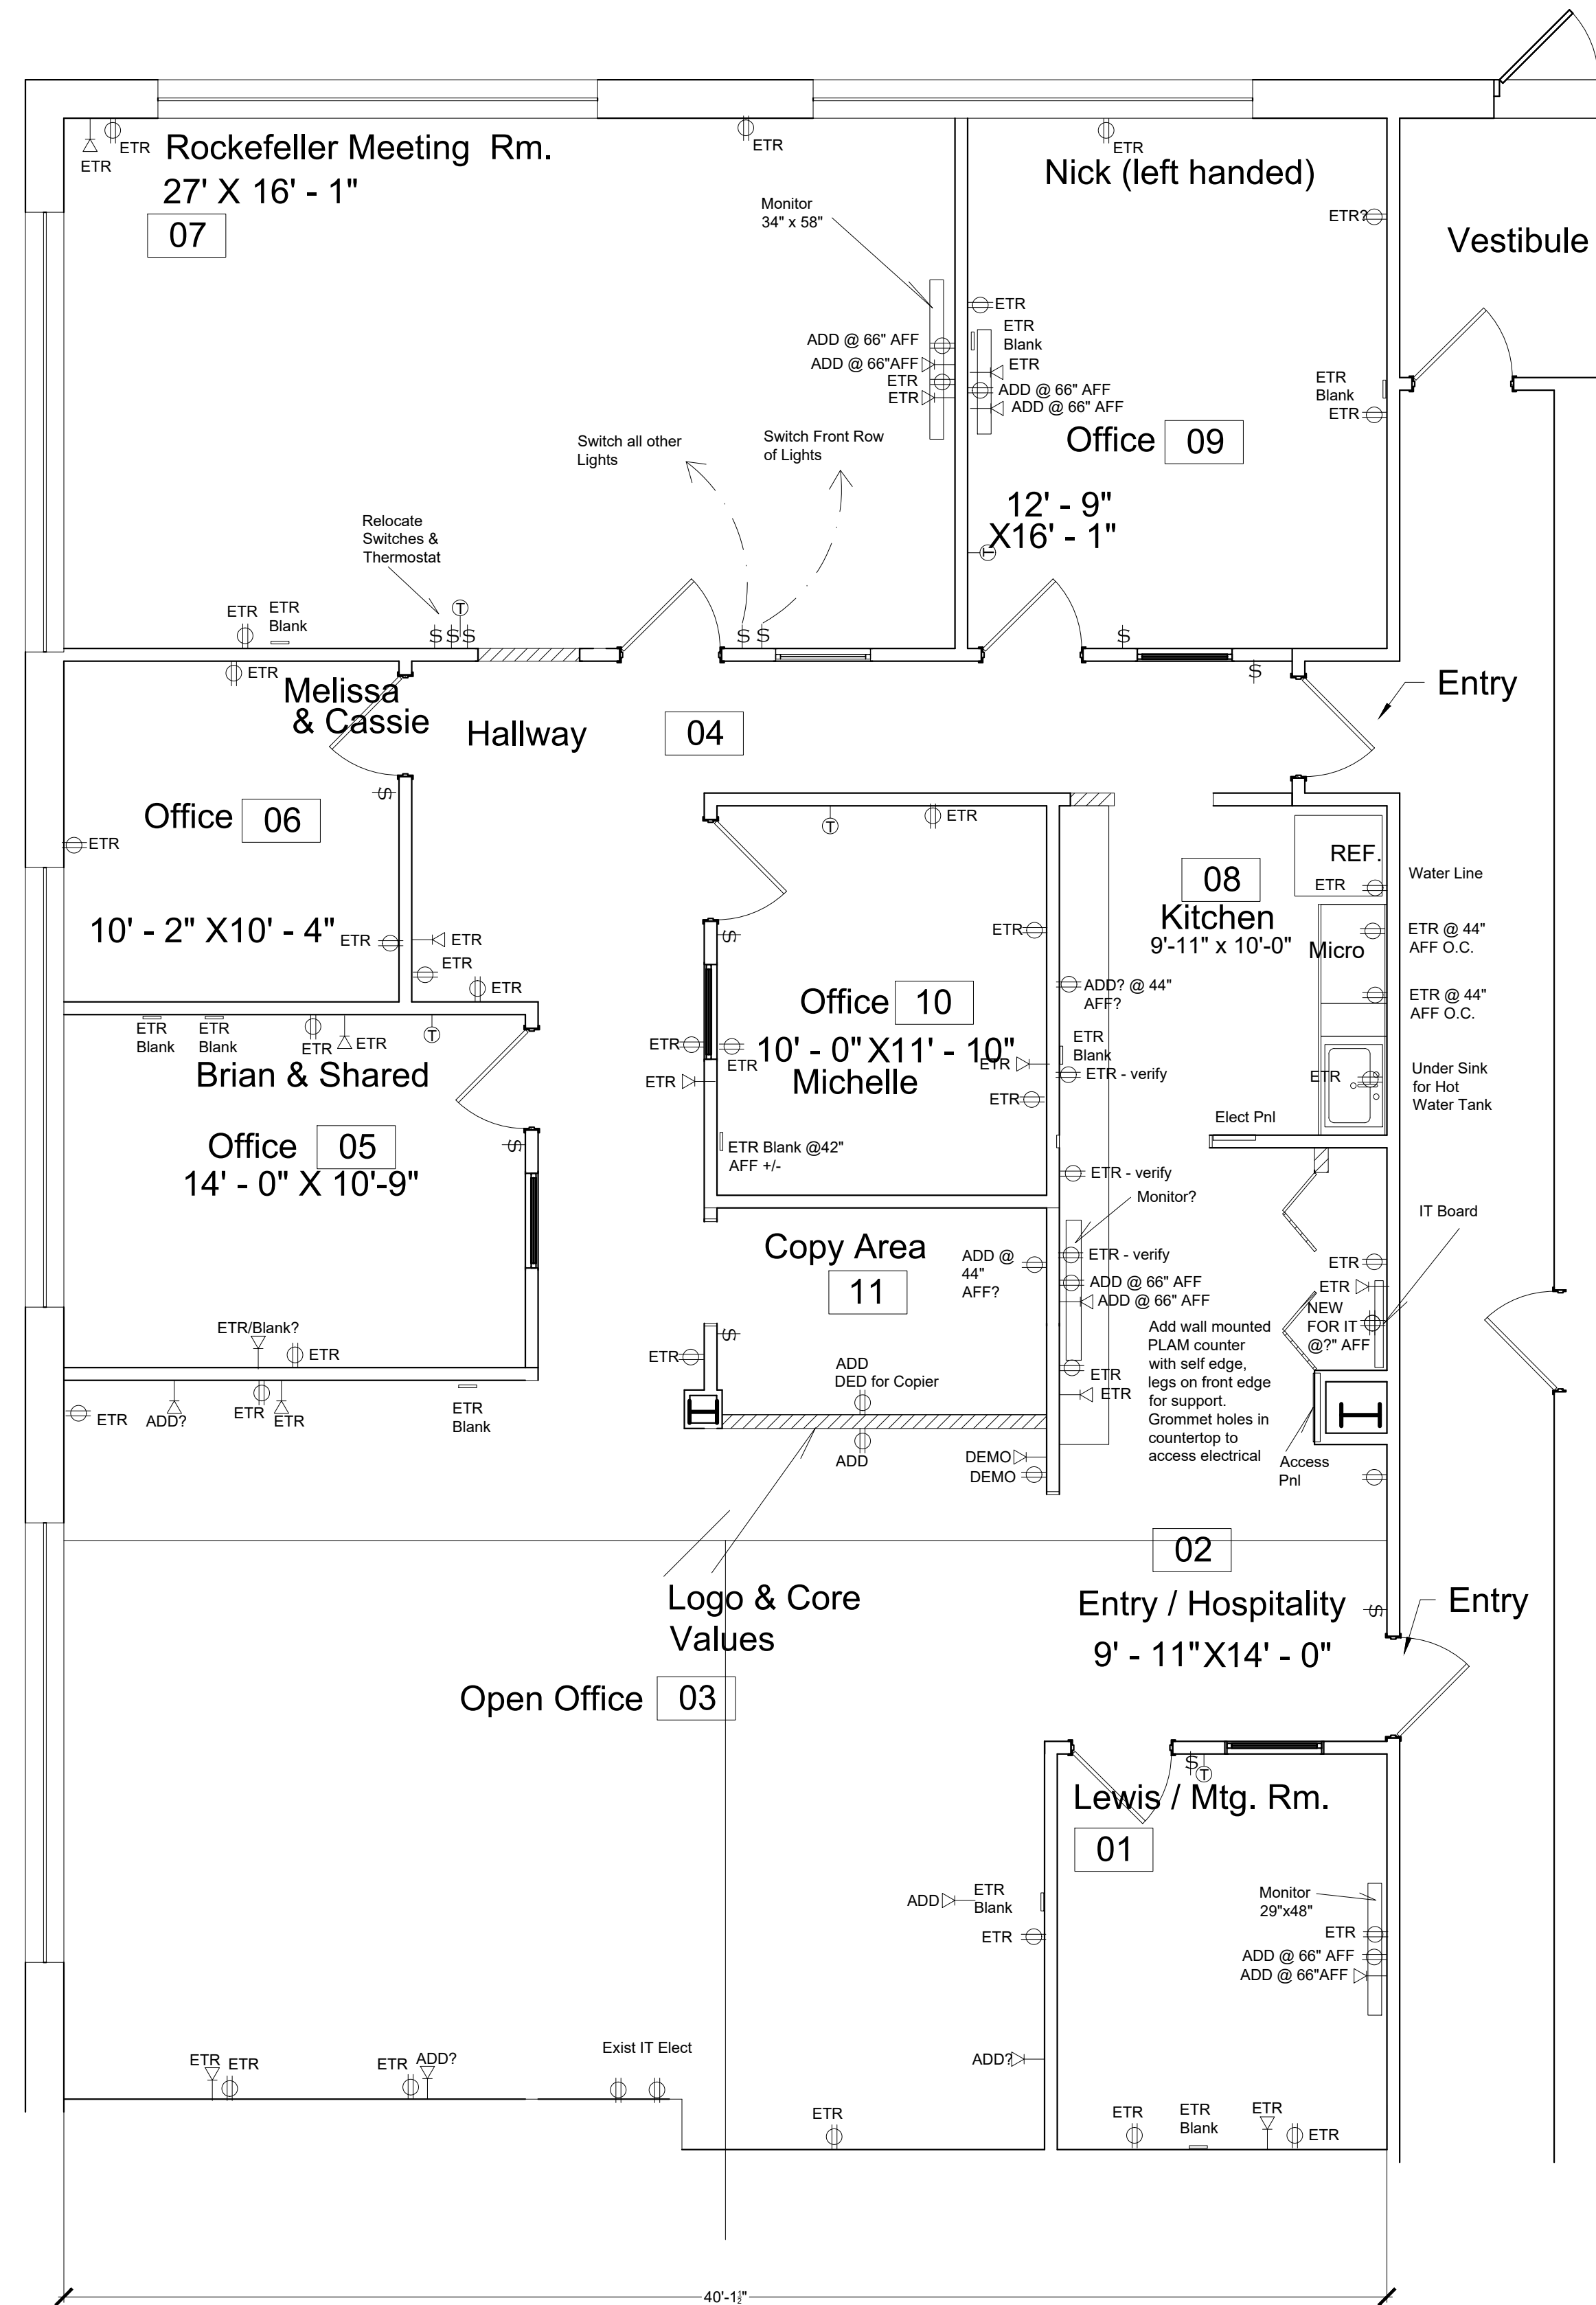

ELECTRICAL PLAN

Scale: 1/4" = 1'
 Date Feb. 26, 2021
 Revised: 3/3, 3/23,
 3/23 V-2, 3/31

Five Lakes Pro
 Pepper Pike Place
 30195 Chagrin Blvd.
 Pepper Pike, OH 44124

Fitzgibbons Design
 Beth Fitzgibbons, ASID, LEED AP, ID+C
 26906 Wolf Road
 Bay Village, OH 44140
 440-346-3651
 bfitzdesigns@gmail.com